

4




3

2




1




UL508A

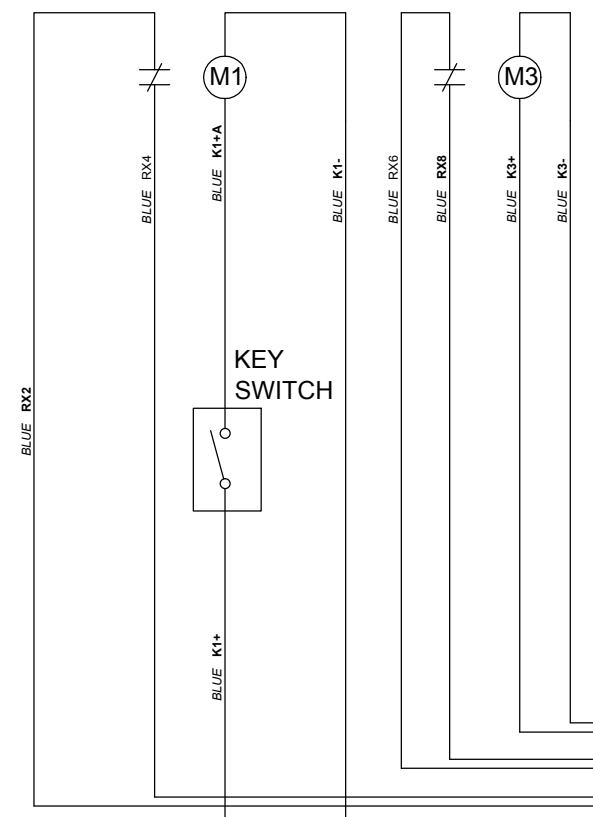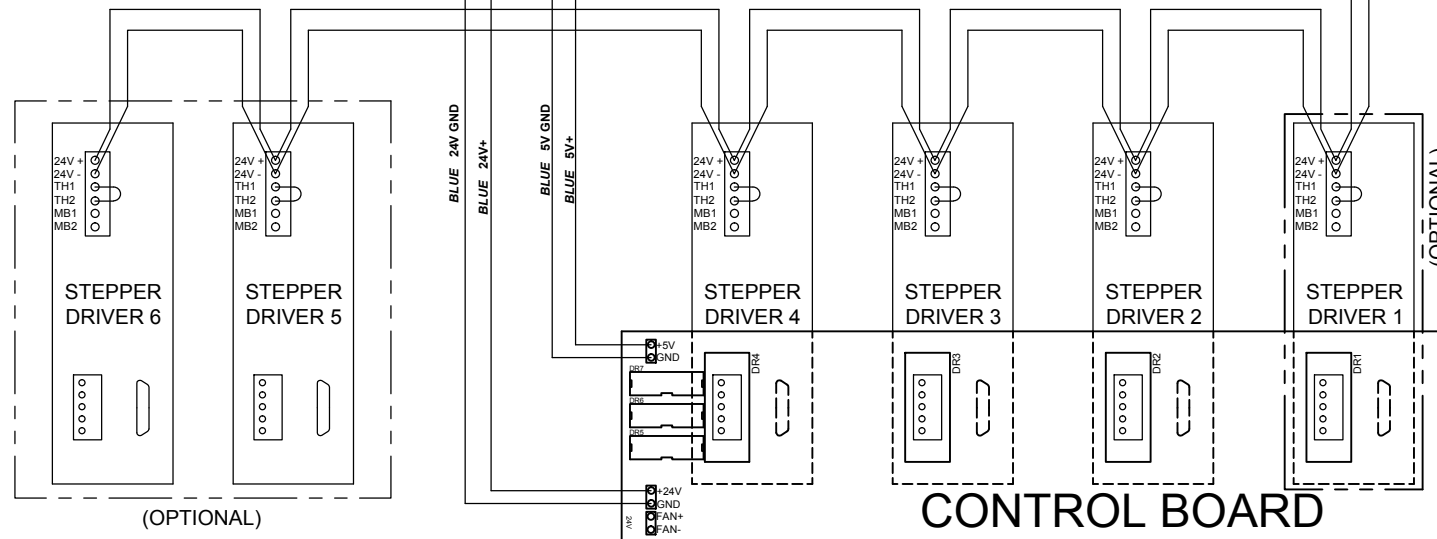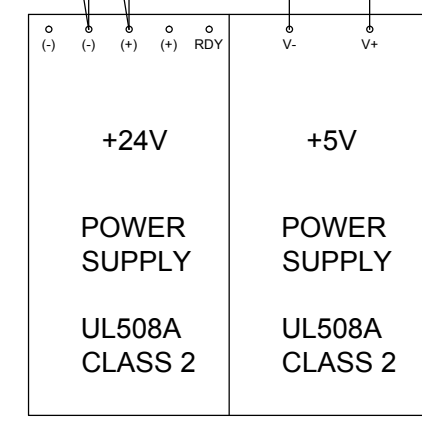

ALL EXTERNAL DEVICES CONNECTED TO CONTROL BOARD TERMINALS ARE PROTECTED BY 5VDC AND 24VDC CLASS 2 POWER SUPPLIES

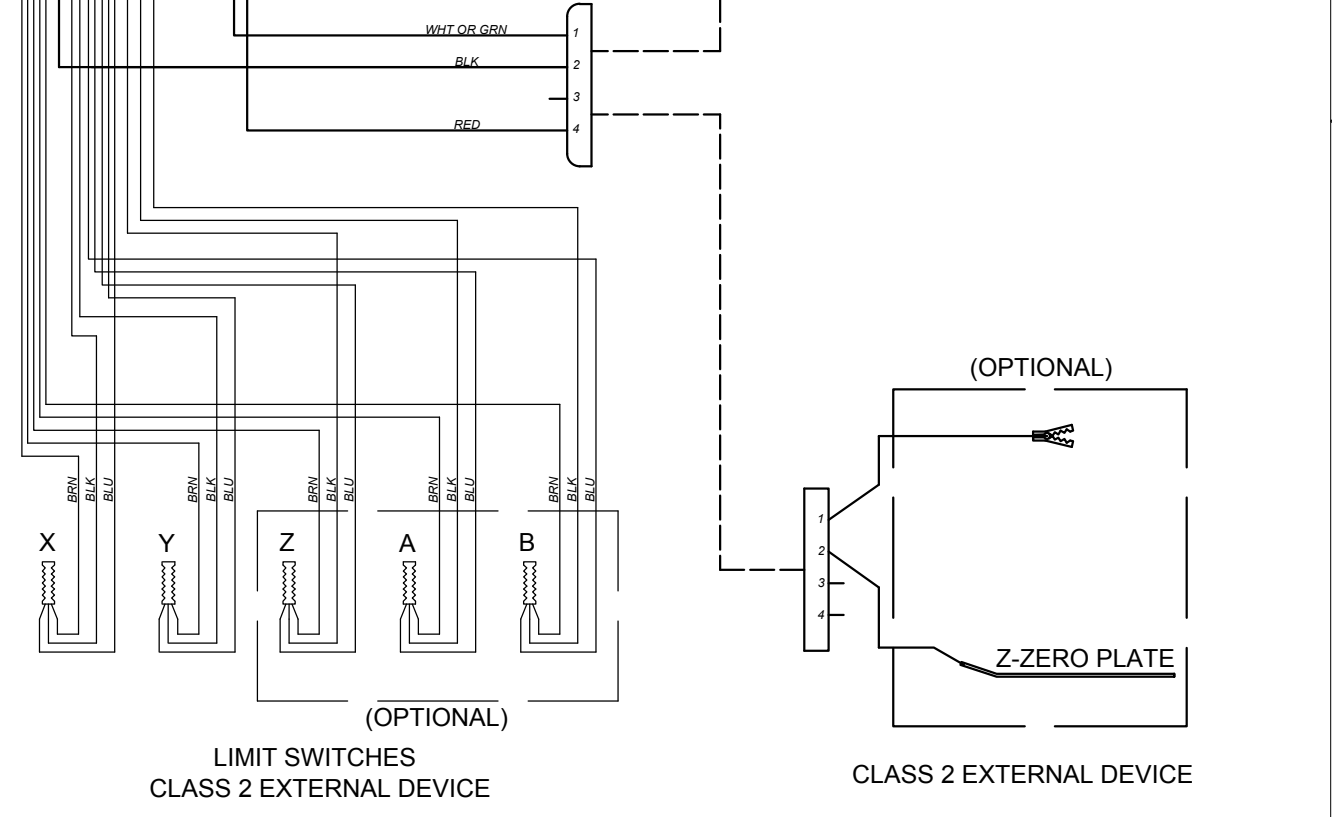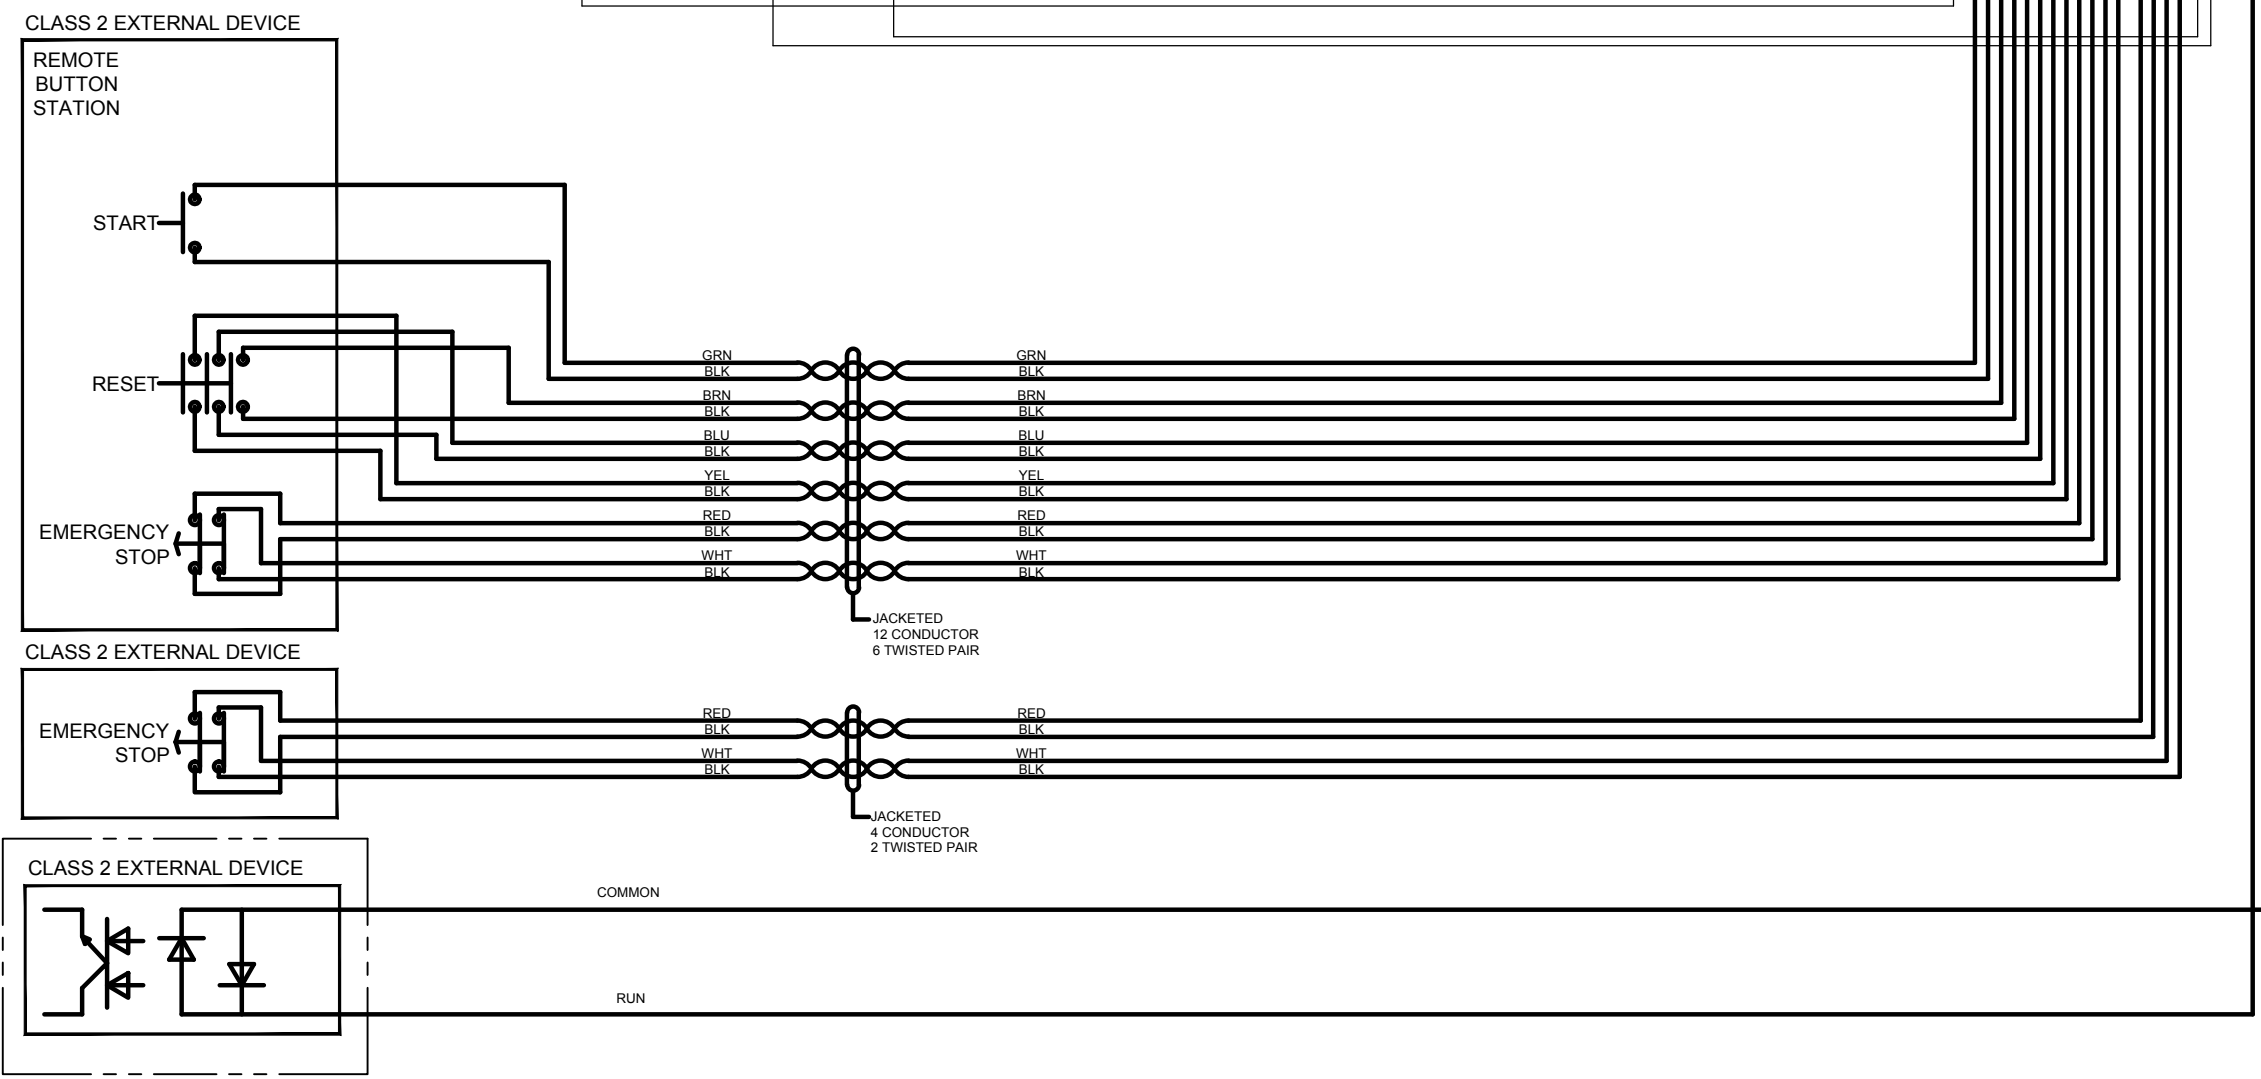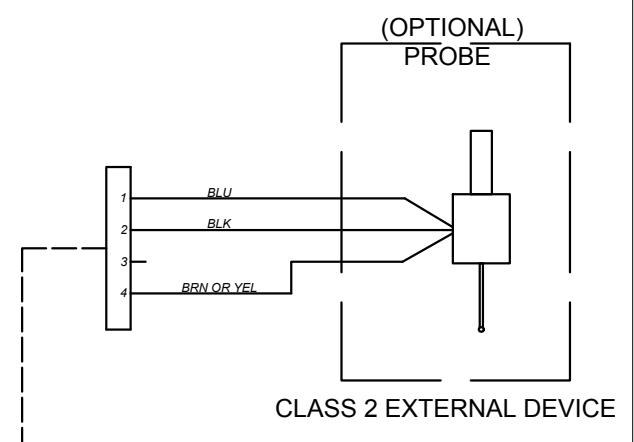

CONTROL DIAGRAM - 1 CUTTING HEAD

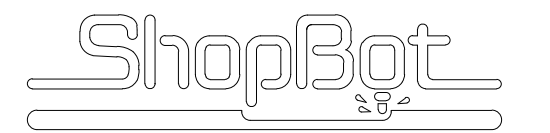

Durham, North Carolina

DIM UNITS: MM SCALE: NONE

THIS DOCUMENT CONTAINS CONFIDENTIAL INFORMATION OF SHOPBOT TOOLS. IT IS NOT TO BE REPRODUCED BY ANY MEANS OR USED TO FURNISH INFORMATION TO OTHERS WITHOUT THE EXPRESS CONSENT TO THE OWNER. THE INFORMATION SHALL BE USED BY RECIPIENTS ONLY AS EXPRESSLY APPROVED BY OWNER AND THIS DOCUMENT SHALL BE RETURNED TO OWNER UPON REQUEST. ©2008, SHOPBOT TOOLS, INC., ALL RIGHTS RESERVED

TITLE		CONTROL DIAGRAM-1 HEAD			
DRAWN	DATE	CHECKED	DATE	APPROVED	DATE
KWP	10/23/14	-	-	-	-
SIZE	DRAWING NUMBER		REV		
C	004119-00		1		
PART NUMBER		004119-00		SHEET 1 OF 1	

1	441	2/6/17	GAB	Add UL label and modify notes	-
REV	CHG NOTICE	DATE	BY	REVISION DESCRIPTION	APVD

4

3

2

1

D

C

B

A