


4

3

2

1

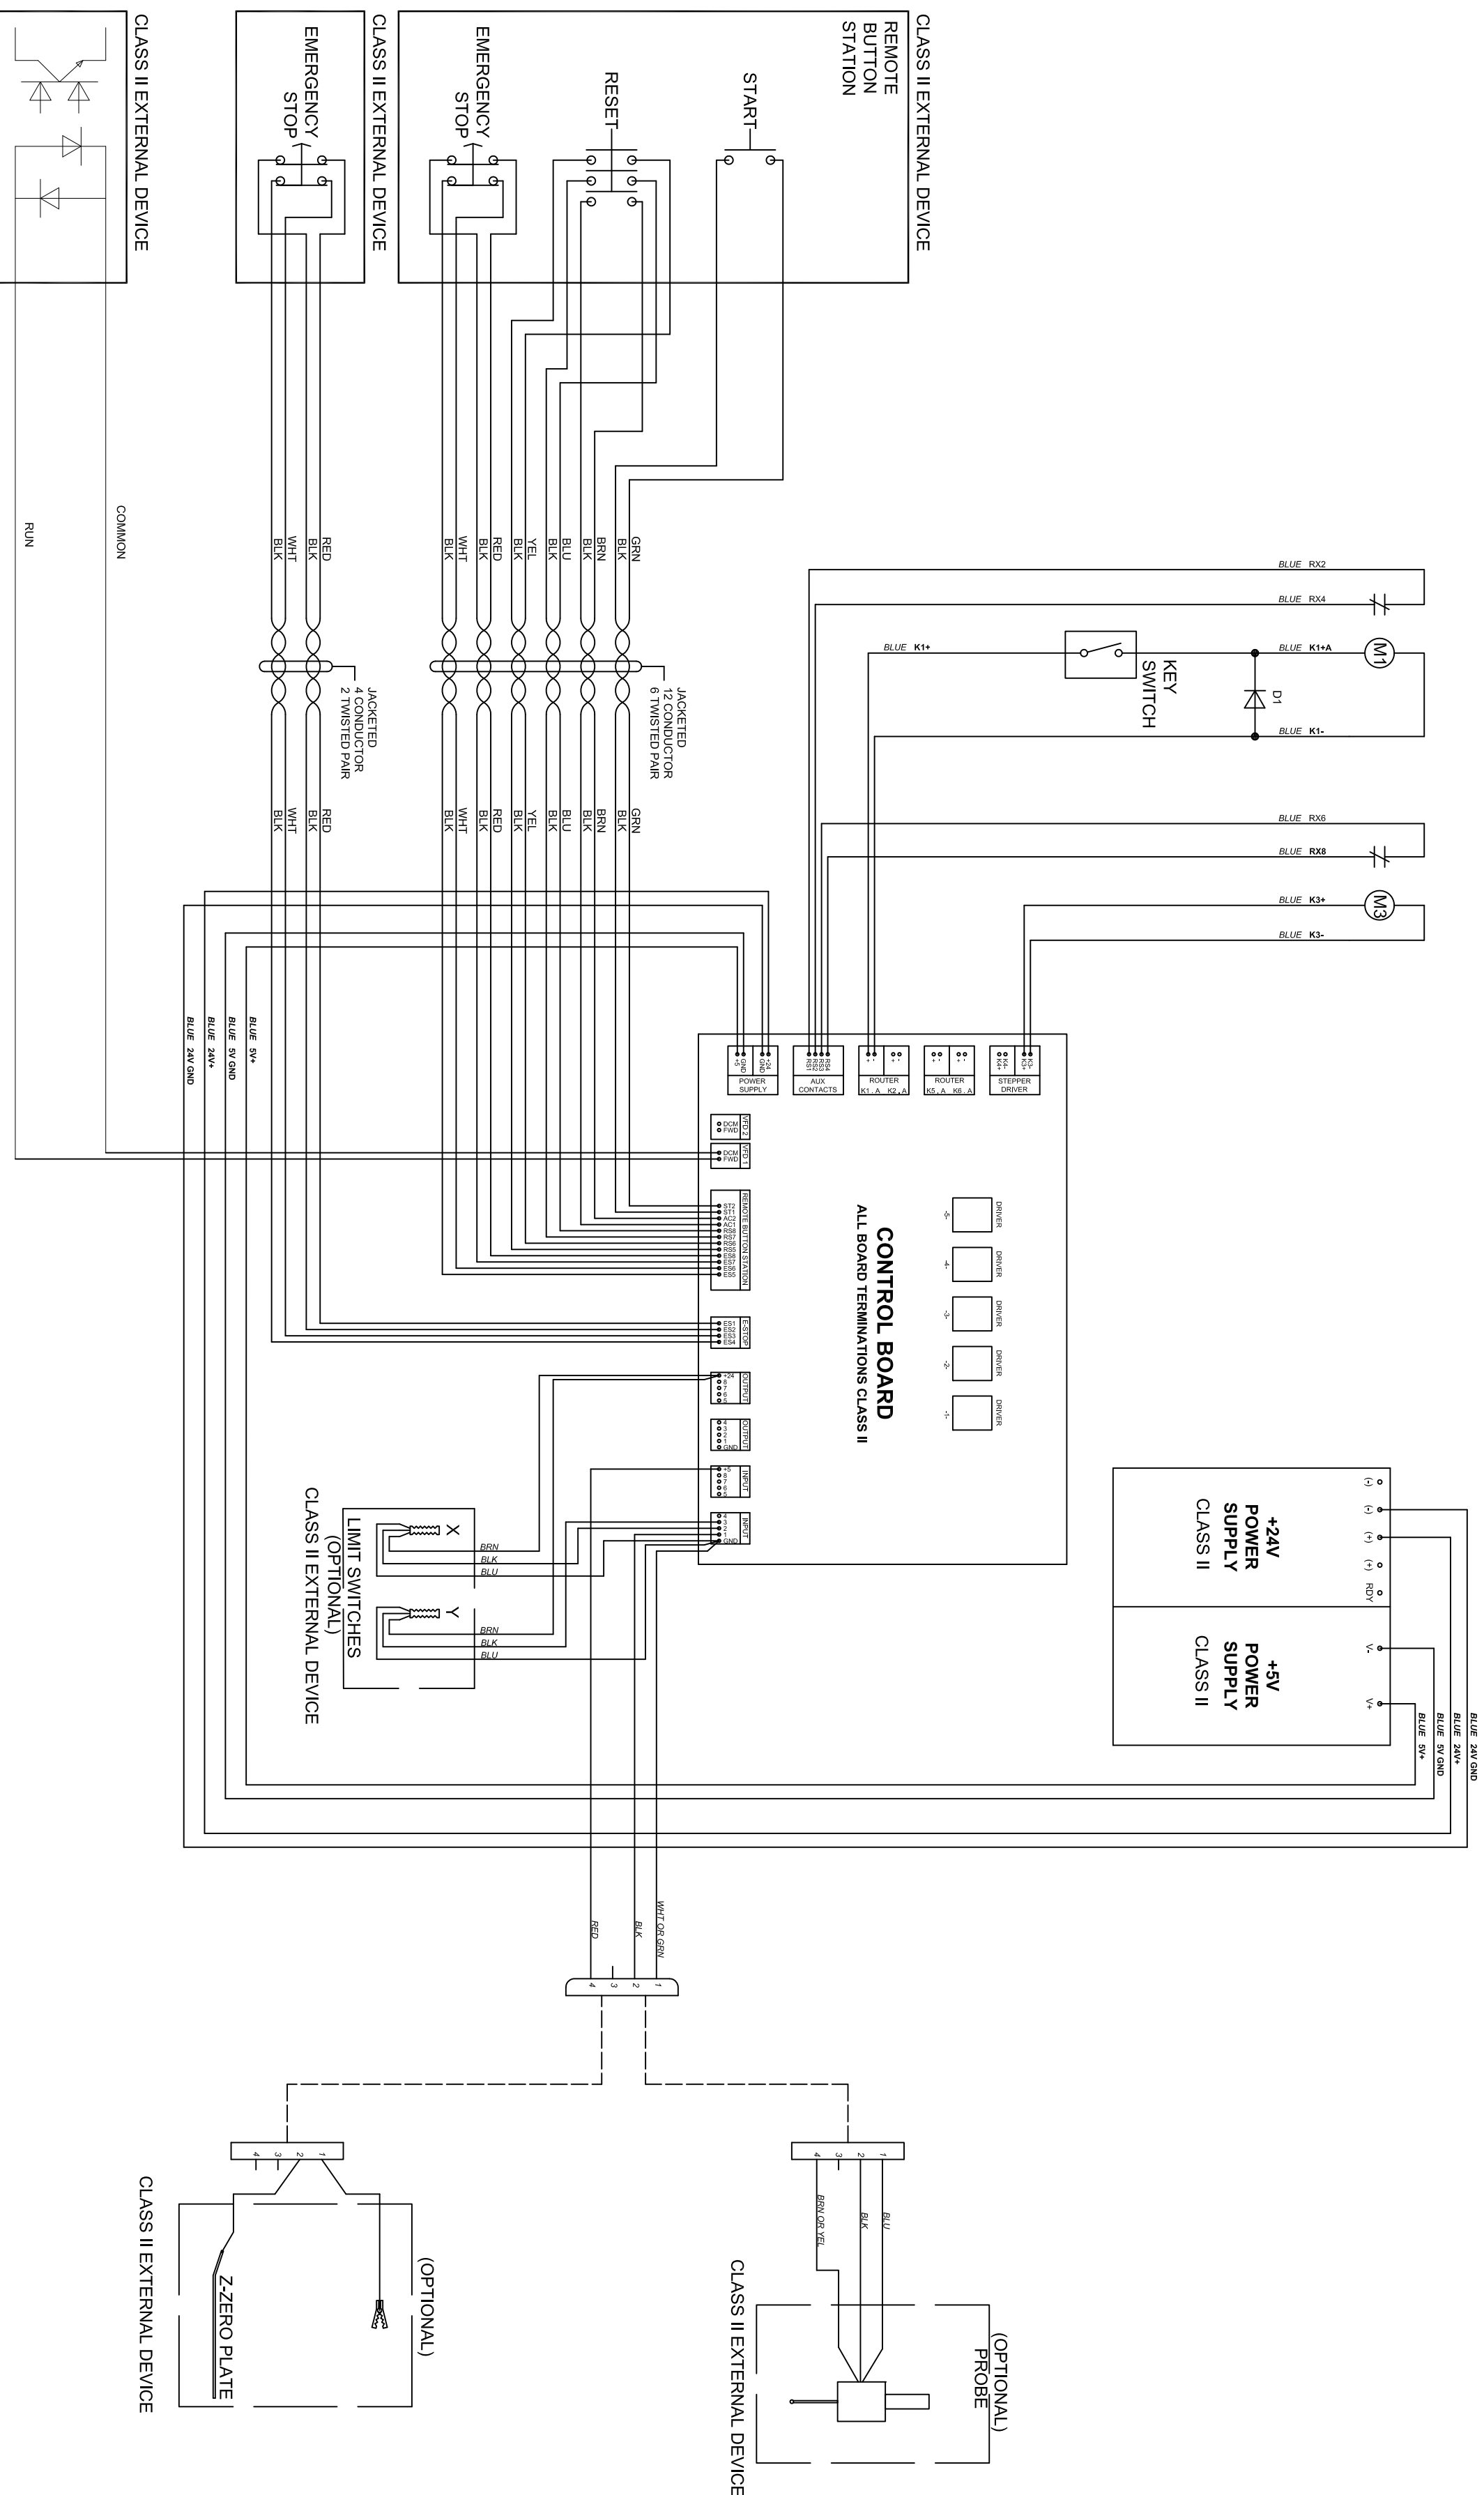

# CONTROL DIAGRAM - 1 ROUTER (DOMESTIC)

REV	CHG NOTICE	DATE	BY	REVISION DESCRIPTION	APVD
1	ECH#270	09OCT12	KWP	CHANGED Z-ZERO PLATE TO PLUG-IN STYLE	-
<p><b>ShopBot</b> Durham, North Carolina</p> <p>TITLE: CONTROL DIAGRAM-1 ROUTER (DOMESTIC)</p> <p>DRAWN: KWP DATE: 05/10/12</p> <p>CHECKED: DATE: APPROVED: DATE:</p> <p>SIZE: DRAWING NUMBER: <b>003327-00</b></p> <p>PART NUMBER: 003327-00 SHEET 1 OF 1</p>					

A

B

C

D

A

B

C

D

4

3

2

1