


4

3

2

1

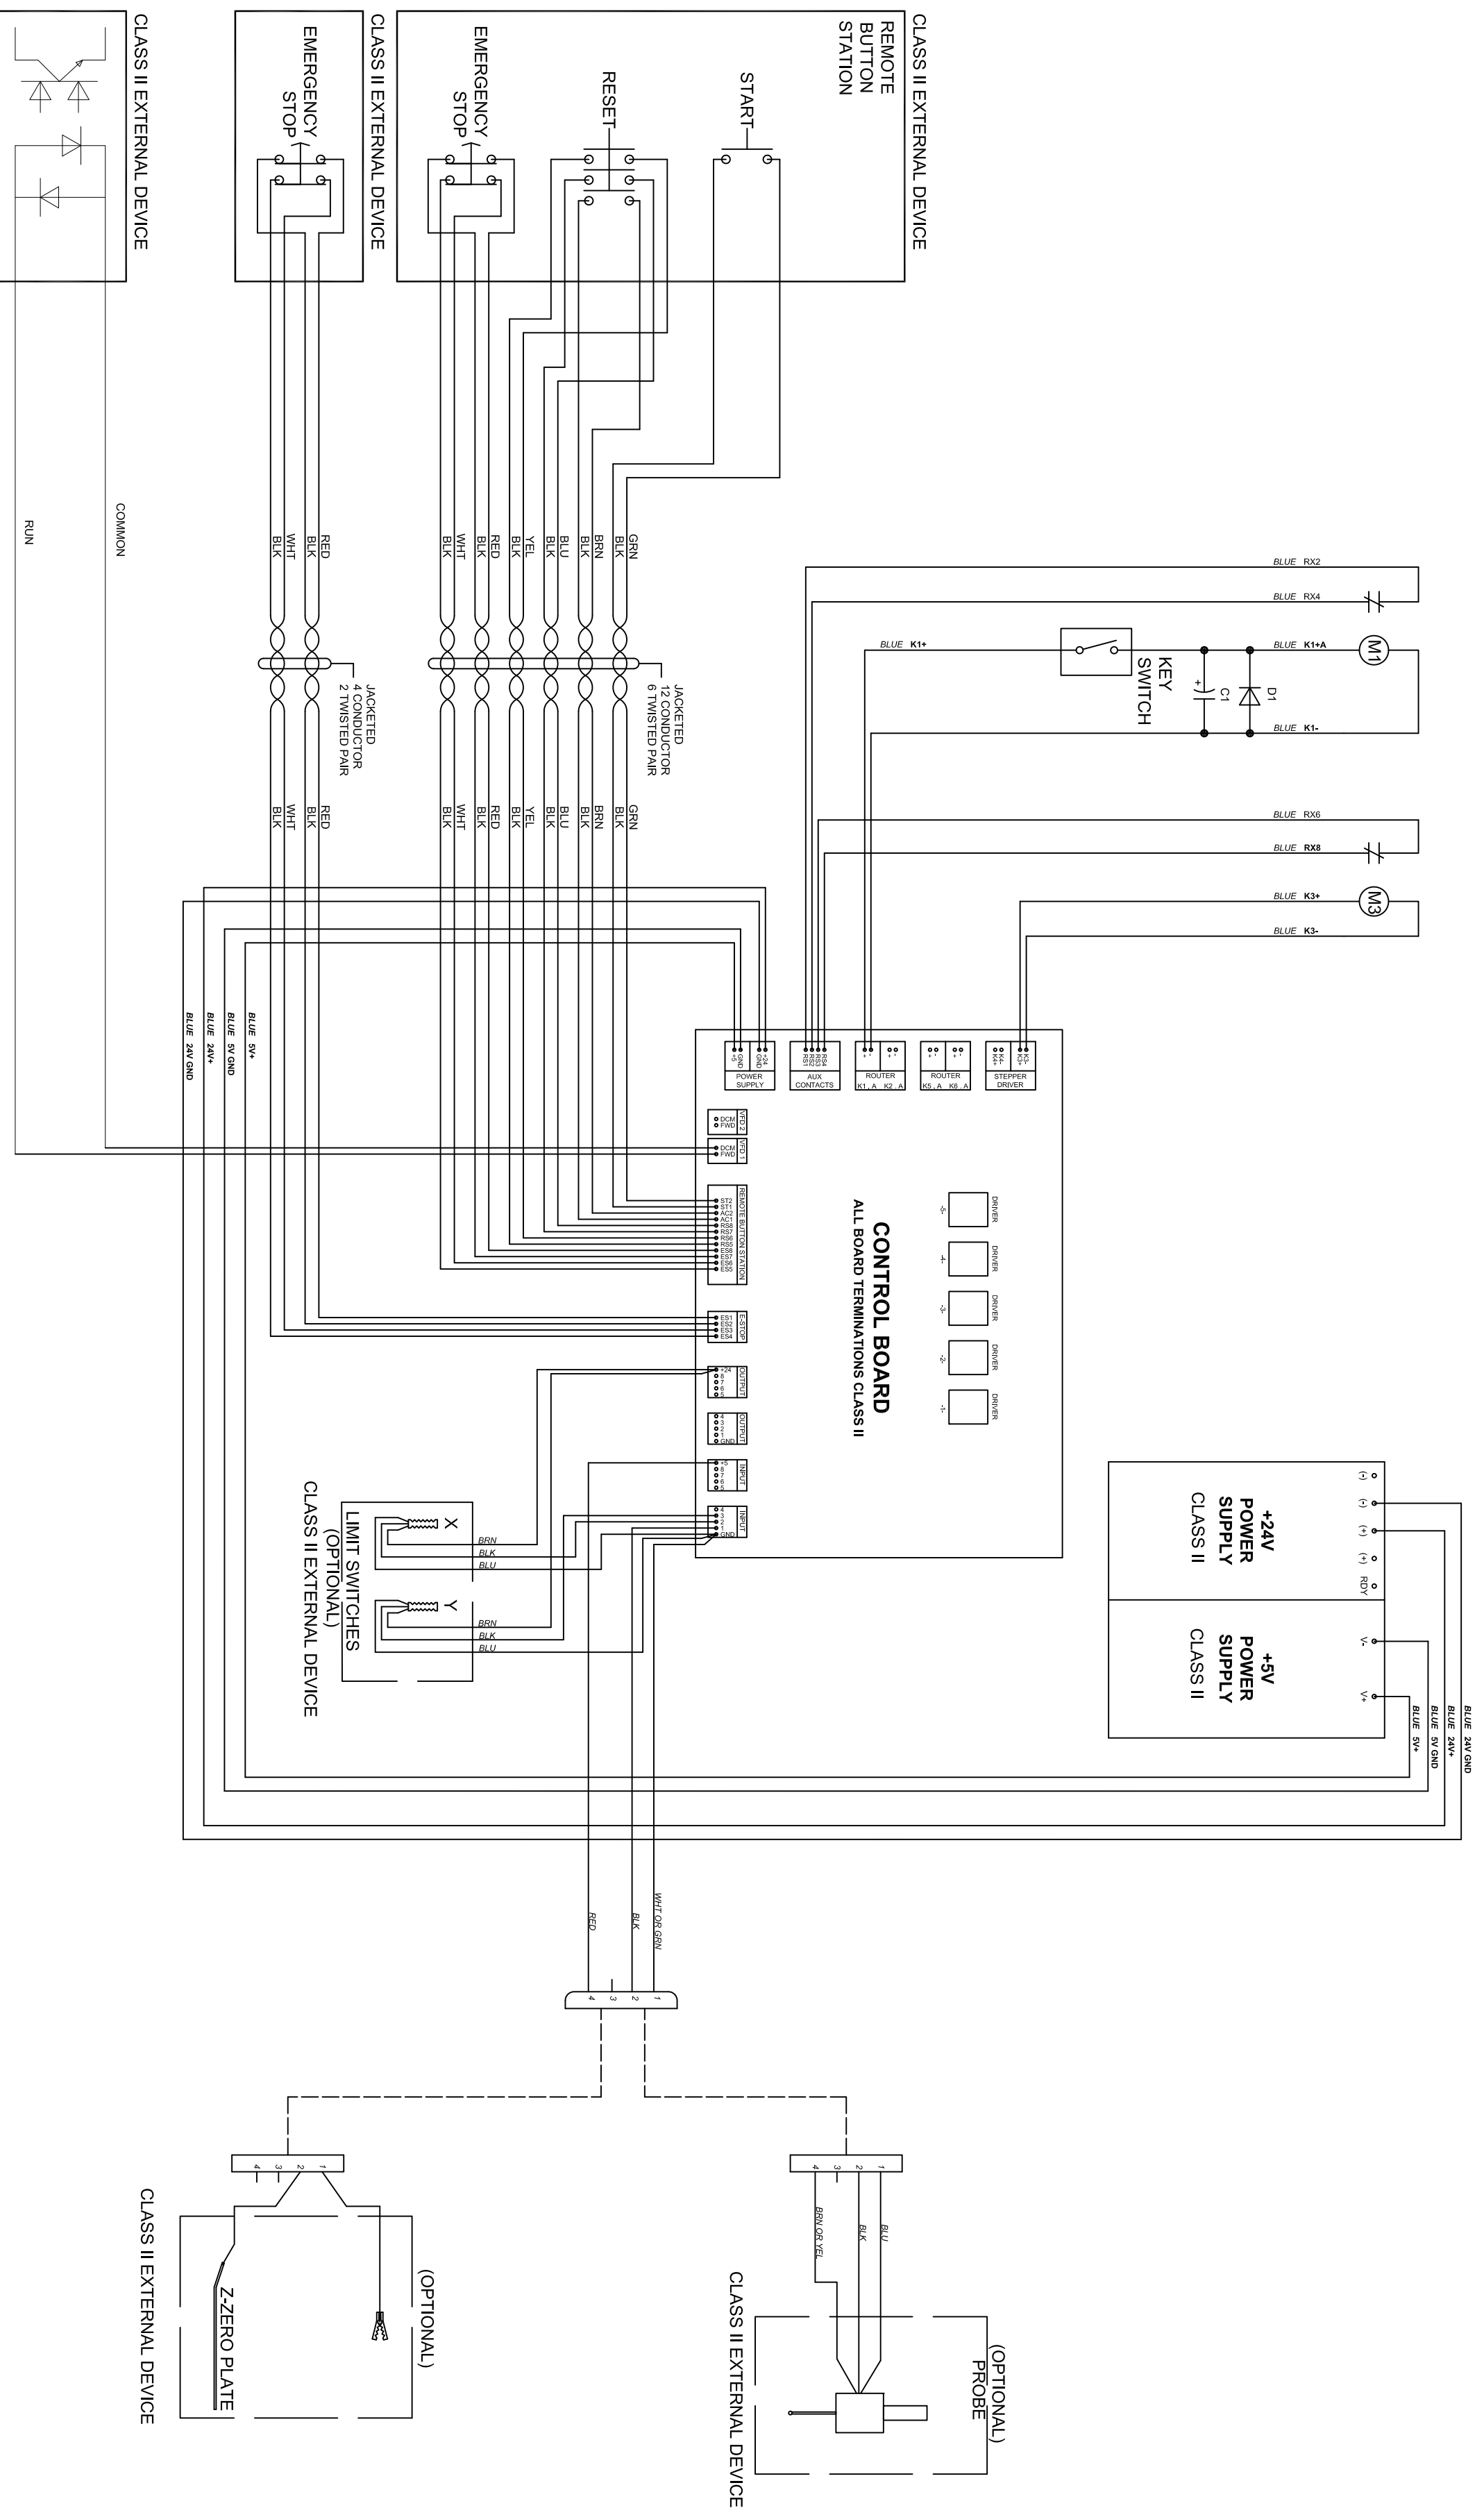

# CONTROL DIAGRAM - 1 SPINDLE (DOMESTIC)

REV	CHG NOTICE	DATE	BY	REVISION DESCRIPTION
6	ECH#270	09OCT12	KWP	CHANGED Z-ZERO PLATE TO PLUG-IN STYLE
APVD				
<p><b>ShopBot</b> Durham, North Carolina</p> <p><b>CONTROL DIAGRAM-1 SPINDLE (DOMESTIC)</b></p> <p>DATE: 05/05/05 CHECKED: AAP DATE: 05/07/07 APPROVED: GAB</p> <p>DATE: 05/07/07</p> <p>SIZE: DRAWING NUMBER <b>002010-00</b></p> <p>PART NUMBER: 002010-00 SHEET 1 OF 1</p>				

A

B

C

D

A

B

C

D

4

3

2

1