

4

3

2

1

D

D

C


C

B

B

A

A

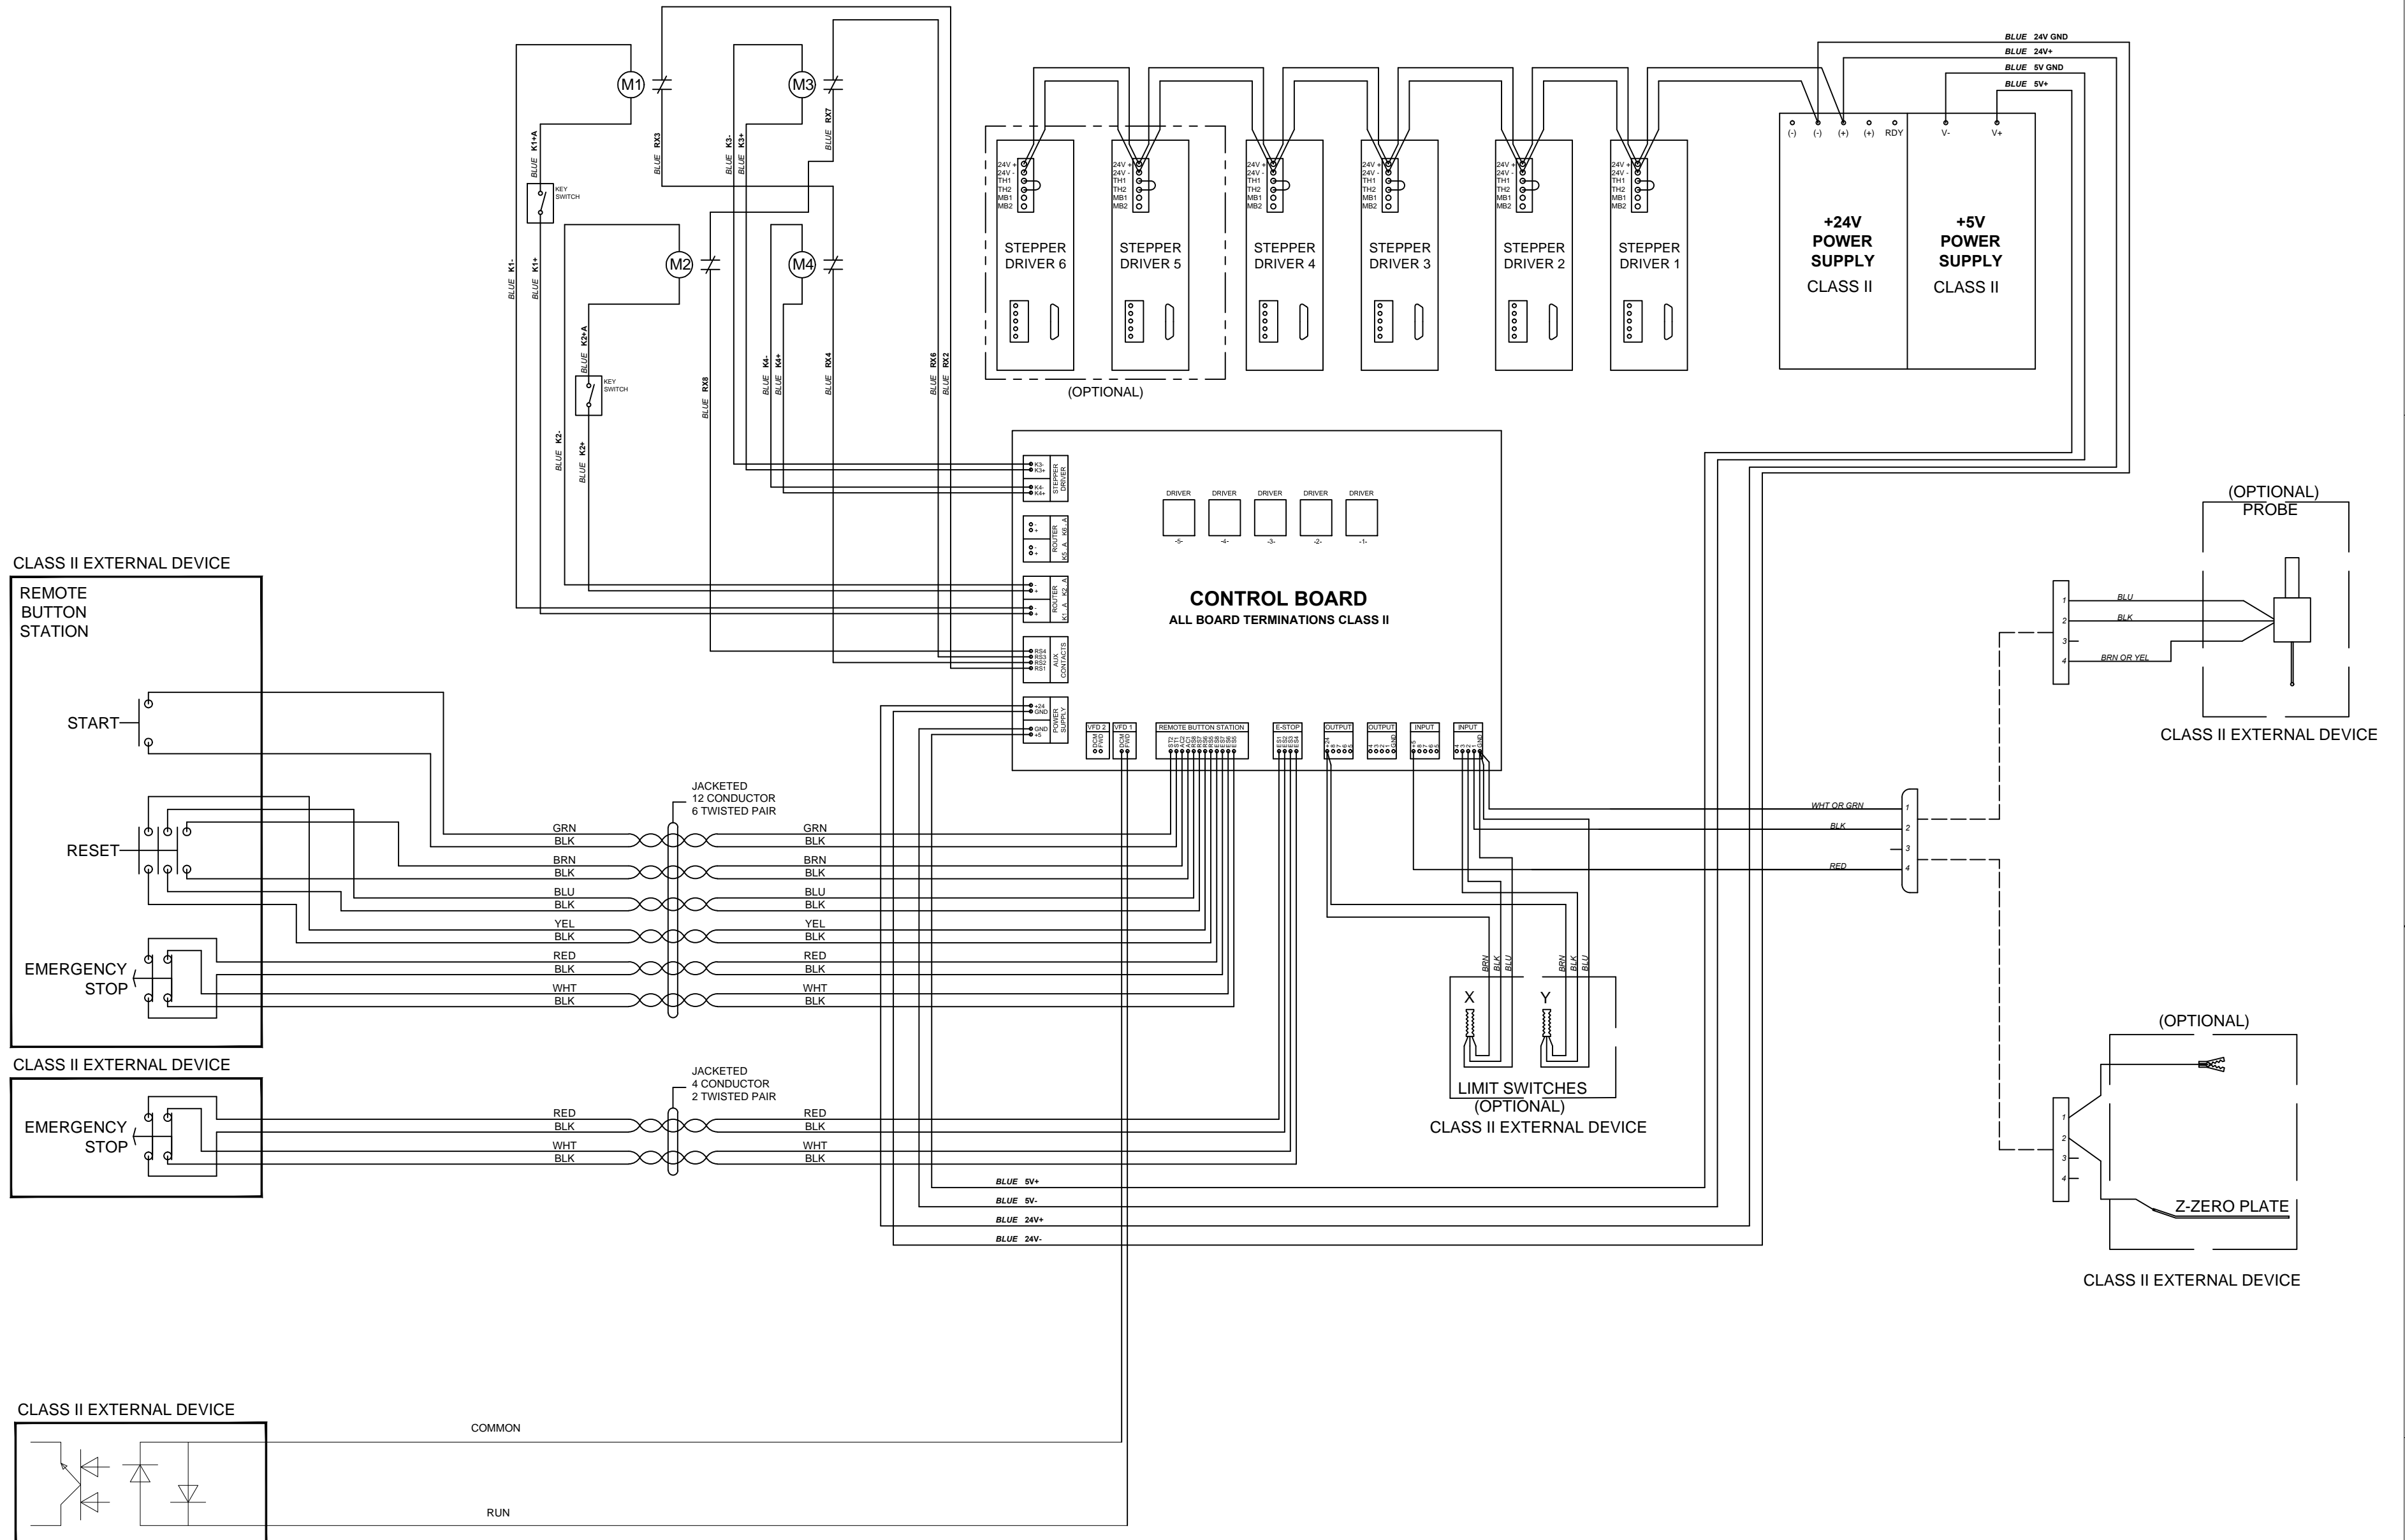

CONTROL DIAGRAM - 1 SPINDLE (INTERNATIONAL)

DIM UNITS: MM SCALE: NONE
 THIS DOCUMENT CONTAINS CONFIDENTIAL INFORMATION OF SHOPBOT TOOLS. IT IS NOT TO BE REPRODUCED BY ANY MEANS OR USED TO FURNISH INFORMATION TO OTHERS WITHOUT THE EXPRESS CONSENT TO THE OWNER. THE INFORMATION SHALL BE USED BY RECIPIENTS ONLY AS EXPRESSLY APPROVED BY OWNER AND THIS DOCUMENT SHALL BE RETURNED TO OWNER UPON REQUEST.
 ©2008, SHOPBOT TOOLS, INC., ALL RIGHTS RESERVED



TITLE CONTROL DIAGRAM-1 SPINDLE (INTERNATIONAL)					
DRAWN KWP	DATE 02/13/13	CHECKED -	DATE -	APPROVED -	DATE -
SIZE C	DRAWING NUMBER 002198-00			REV 3	
PART NUMBER 002198-00			SHEET 1 OF 1		

3	-	14AUG14	KWP	REMOVED DIODES AND CAPACITORS FROM CONTACTORS, ADDED 24V POWER TO DRIVERS	
REV	CHG NOTICE	DATE	BY	REVISION DESCRIPTION	APVD

4

3

2

1